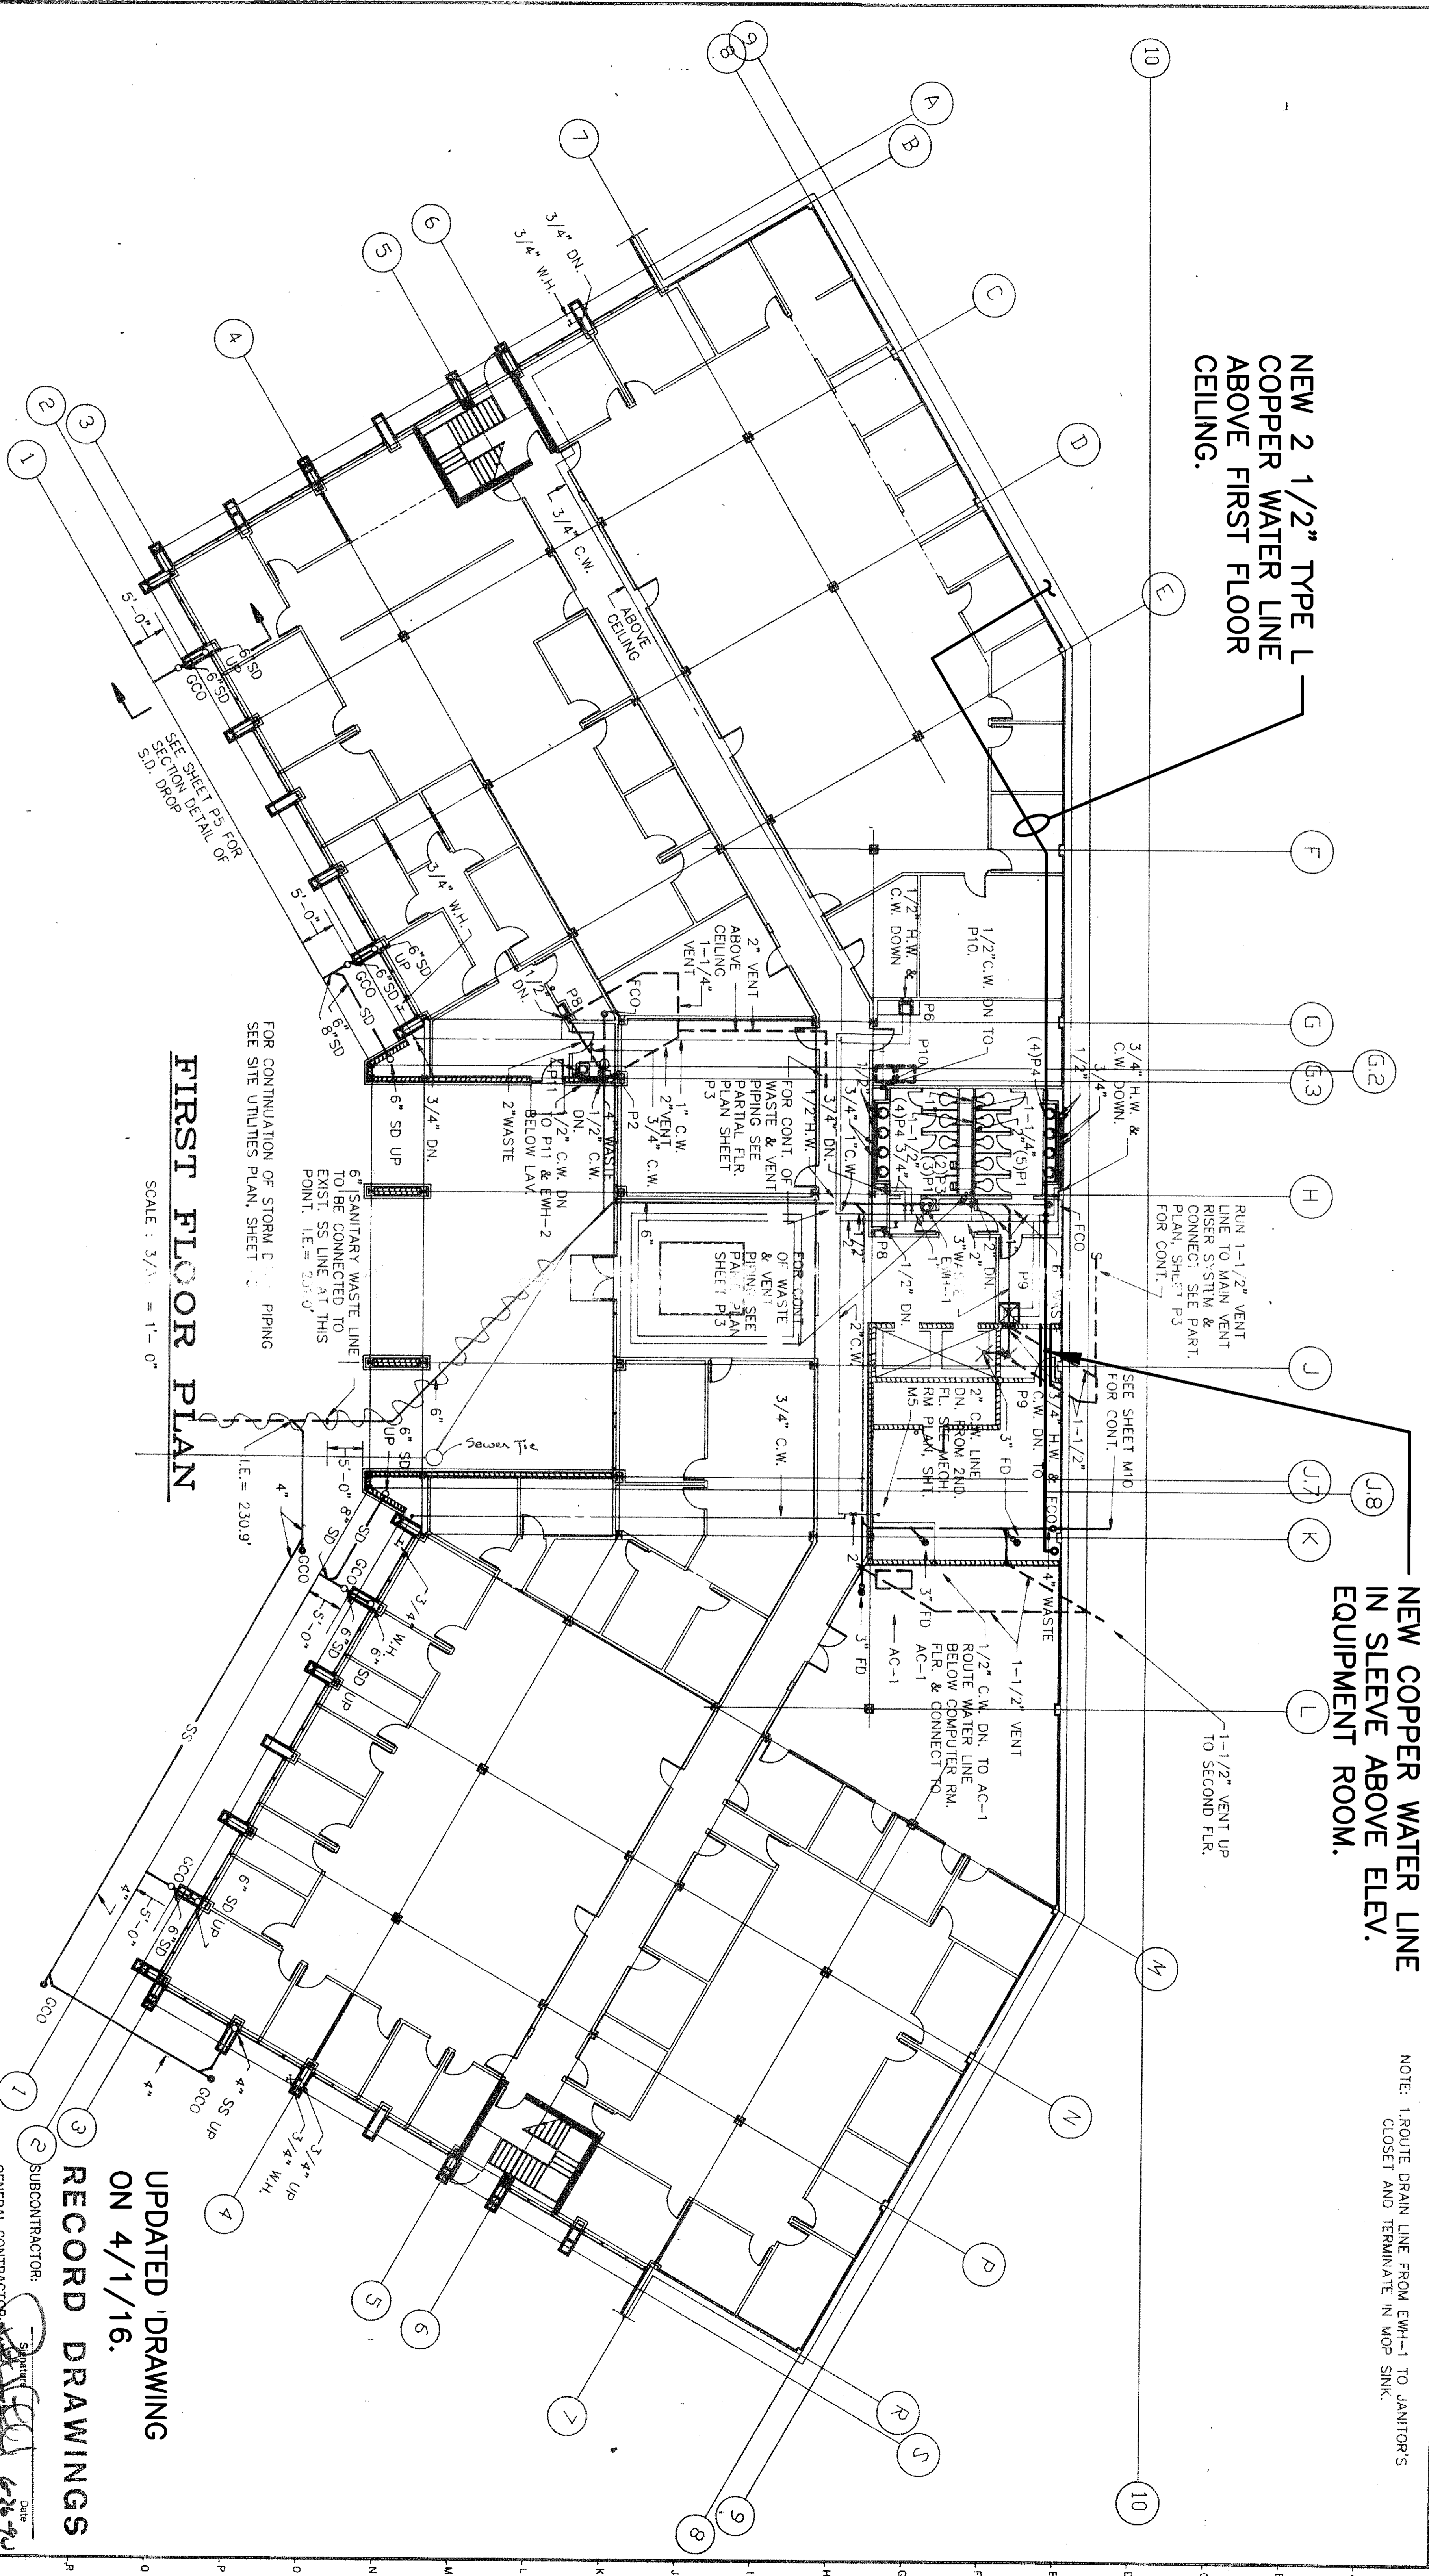


**NEW COPPER WATER LINE
IN SLEEVE ABOVE ELEV.
EQUIPMENT ROOM.**

**NEW 2 1/2" TYPE L
COPPER WATER LINE
ABOVE FIRST FLOOR
CEILING.**

NOTE: 1" ROUTE DRAIN LINE FROM EWH-1 TO JANITOR'S
CLOSET AND TERMINATE IN MOP SINK.

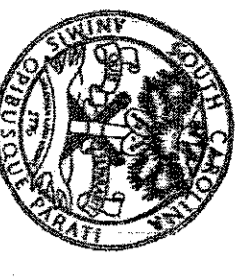
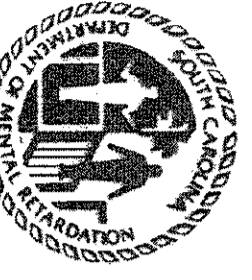
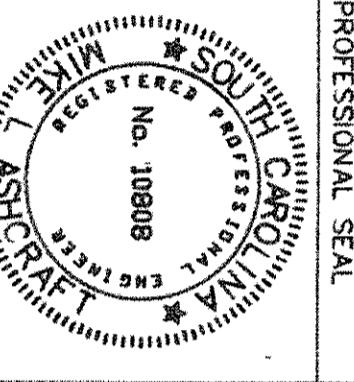


FIRST FLOOR PLAN
SCALE: 3/8" = 1'-0"

**UPDATED DRAWING
ON 4/1/16.**

RECORD DRAWINGS

SUBCONTRACTOR:
GENERAL CONTRACTOR:
GENERAL CONTRACTOR SHALL VERIFY SUBCONTRACTORS
SIGNATURE IF APPLICABLE.

 The State of South Carolina	 DEPARTMENT OF MENTAL RETARDATION	AGENCY OR INSTITUTION PROFESSIONAL SEAL	PROJECT TITLE CENTRAL OFFICE BUILDING PHASE II
		E. FIRM CARLISLE ASSOCIATES 1015 GERVAIS STREET P. O. BOX 11528 COLUMBIA, SC 29211 (803) 252-5232	SHEET TITLE FIRST FLOOR PLUMBING PLAN
DIVISION REVISION NO. DATE BY APP.	REVISION NO. DATE BY APP.	DRAWN BY CHECKED BY FINAL APP.	STATE PROJECT NO. J16-89933 DRAWING NO. 575-P1 DATE 4/1/88
 No. 10898 REGISTERED PROFESSIONAL ENGINEER STATE OF SOUTH CAROLINA		SHEET P1 OF 5	